
 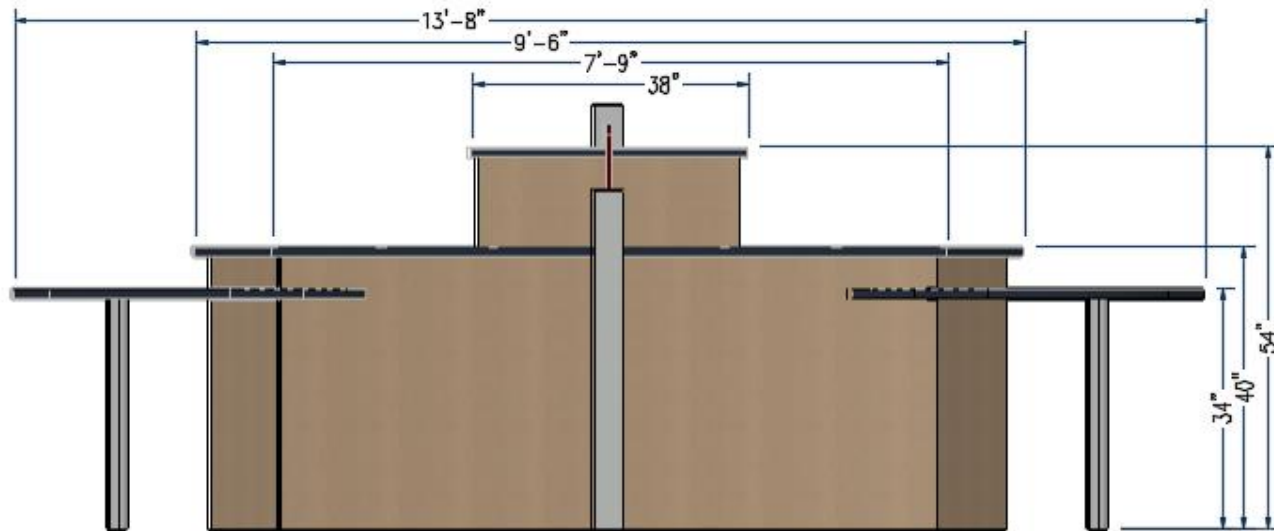



Drawings and renderings are proprietary to FENCO and are for marketing purposes only. Not to be used for reproduction or redistribution.

FIELD CONSULTANT -	DRAWN BY LLW	SCALE	TITLE -	DATE
 UNITED HOSPITAL SUPPLY CORPORATION LAB DESIGN <i>FENCO</i> PO BOX 1238, 4422 ROUTE 130 BURLINGTON, NJ 08018 T: 609-387-7580 • www.lab-design.com • www.fencobankequipment.com			Pod F Plan View	DWG.NO. JOB NO. - SHEET 1 OF 5



Drawings and renderings are proprietary to FENCO and are for marketing purposes only. Not to be used for reproduction or redistribution.

FIELD CONSULTANT -	DRAWN BY LLW	SCALE	TITLE -	DATE
 UNITED HOSPITAL SUPPLY CORPORATION LAB DESIGN <i>FENCO</i>			Pod F	DWG.NO.
PO BOX 1236, 4422 ROUTE 130 BURLINGTON, NJ 08016 T: 609-387-7580 * www.lab-design.com * www.fencobanksequipment.com			Stand-up Front Elevation	JOB NO. -
				SHEET 2 OF 5

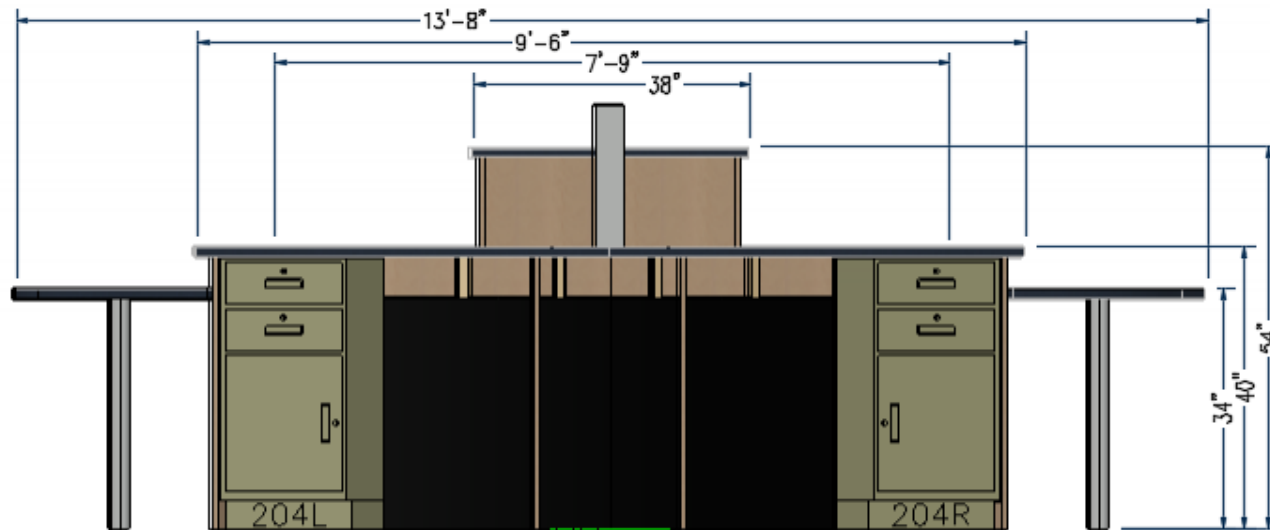


Drawings and renderings are proprietary to FENCO and are for marketing purposes only. Not to be used for reproduction or redistribution.

FIELD CONSULTANT -	DRAWN BY LLW	SCALE	TITLE -	DATE
 UNITED HOSPITAL SUPPLY CORPORATION LAB DESIGN <i>Fenco</i>			Pod F	DWG.NO.
PO BOX 1236, 4422 ROUTE 130 BURLINGTON, NJ 08016 T: 609-887-7580 * www.lab-design.com * www.fencobankequipment.com			Stand-up Rear Elevation	JOB NO. -
				SHEET 3 OF 5



Drawings and renderings are proprietary to FENCO and are for marketing purposes only. Not to be used for reproduction or redistribution.

FIELD CONSULTANT -	DRAWN BY LLW	SCALE N.T.S.	TITLE -	DATE
 UNITED HOSPITAL SUPPLY CORPORATION LAB DESIGN <i>Fenco</i> PO BOX 1236, 4422 ROUTE 130 BURLINGTON, NJ 06016 T: 609-887-7560 * www.lab-design.com * www.fencobanksequipment.com			Pod F Render	DWG.NO. JOB NO. - SHEET 4 OF 5

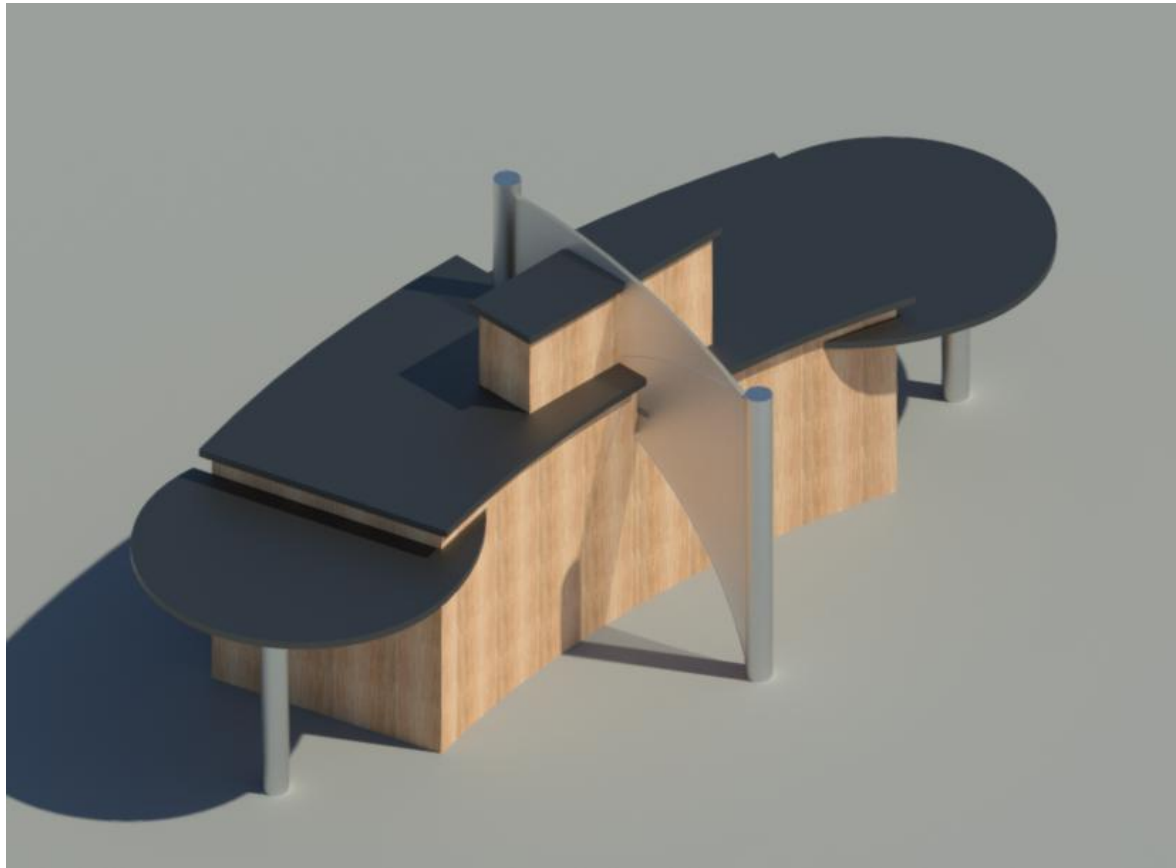

Drawings and renderings are proprietary to FENCO and are for marketing purposes only. Not to be used for reproduction or redistribution.

FIELD CONSULTANT -	DRAWN BY LLW	SCALE N.T.S.	TITLE -	DATE
 UNITED HOSPITAL SUPPLY CORPORATION LAB DESIGN <i>FENCO</i> PO BOX 1238, 4422 ROUTE 130 BURLINGTON, NJ 08016 T: 609-387-7580 * www.lab-design.com * www.fencobankequipment.com			Pod F Render	DWG.NO. JOB NO. - SHEET 5 of 5